


SYMBOL

DESCRIPTION


ONE LINE DIAGRAMS-1

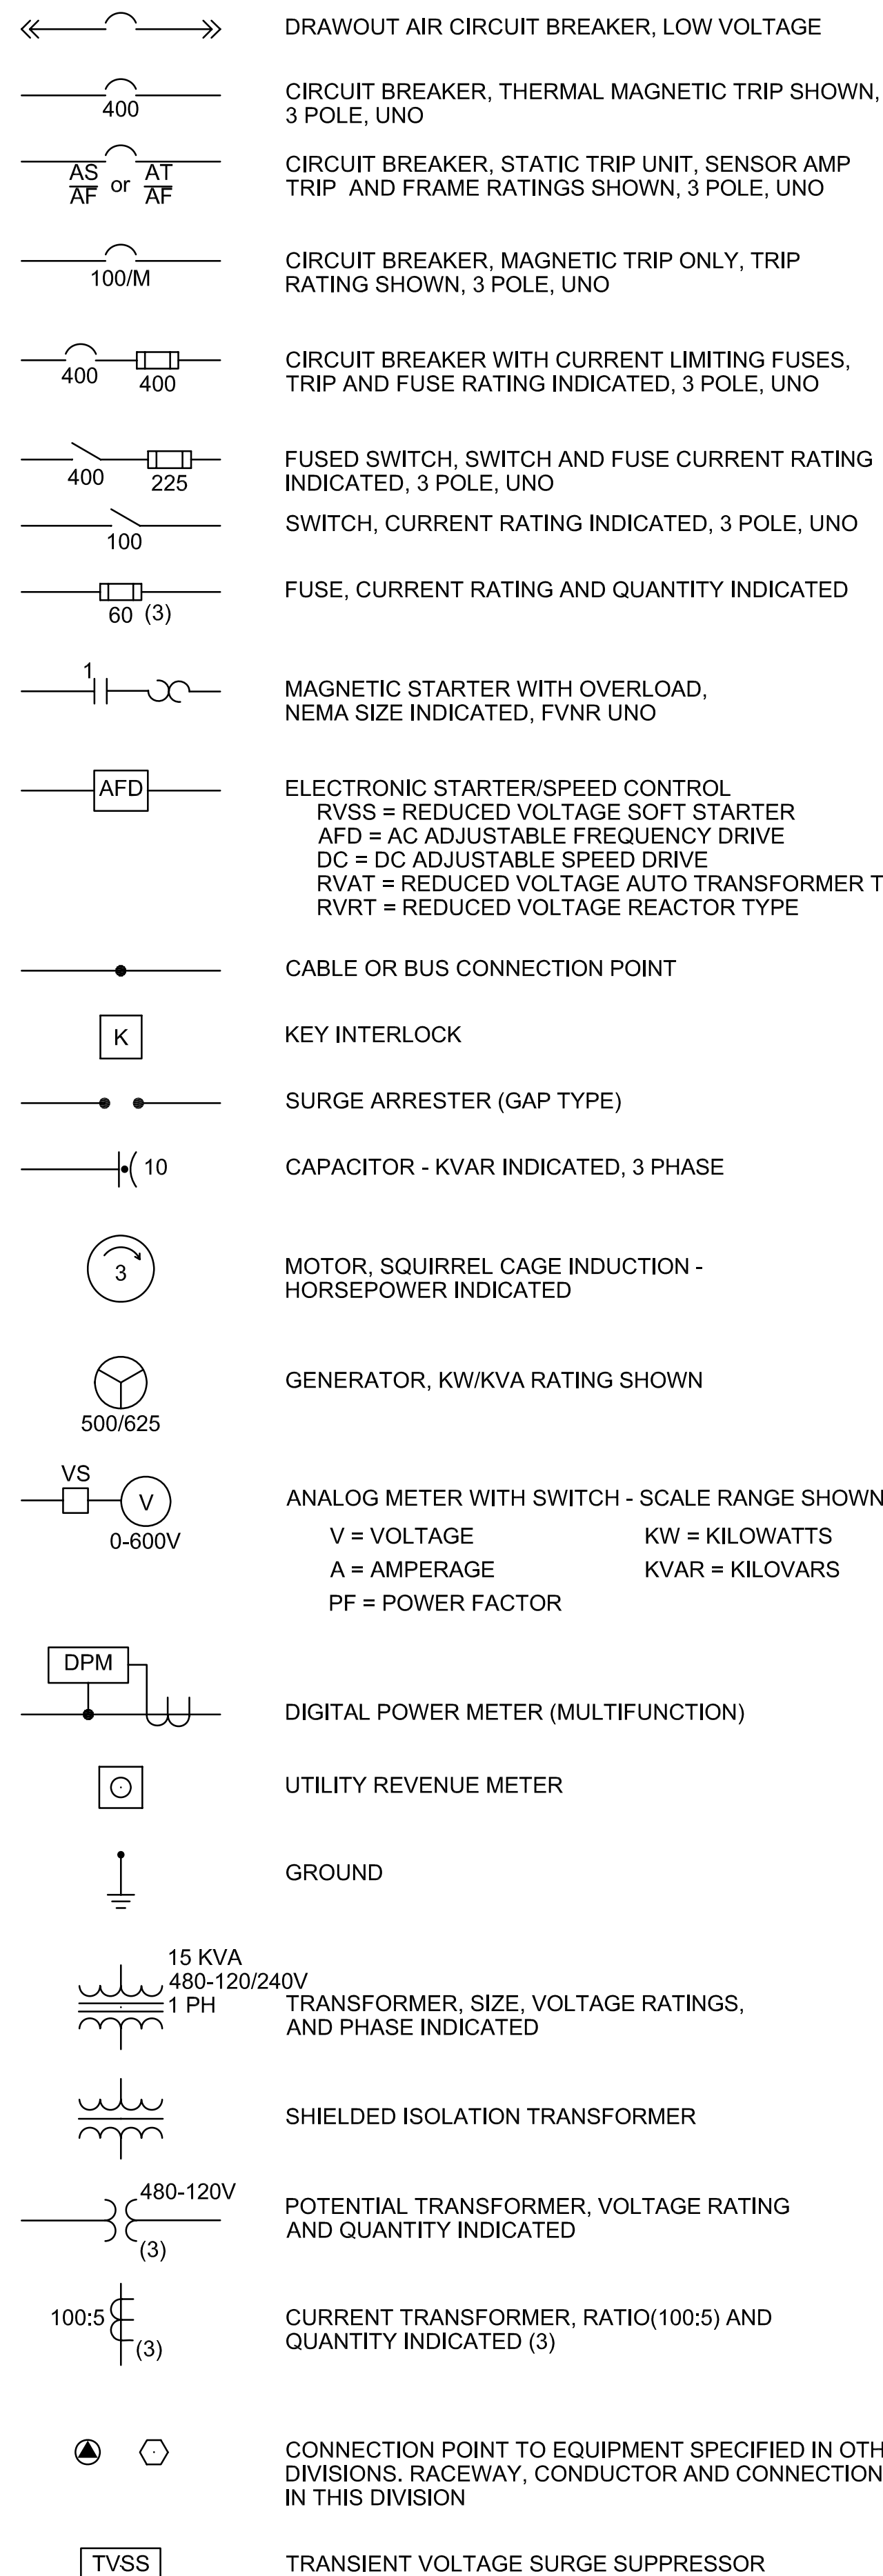

SYMBOL

DESCRIPTION

ONE LINE DIAGRAMS-2

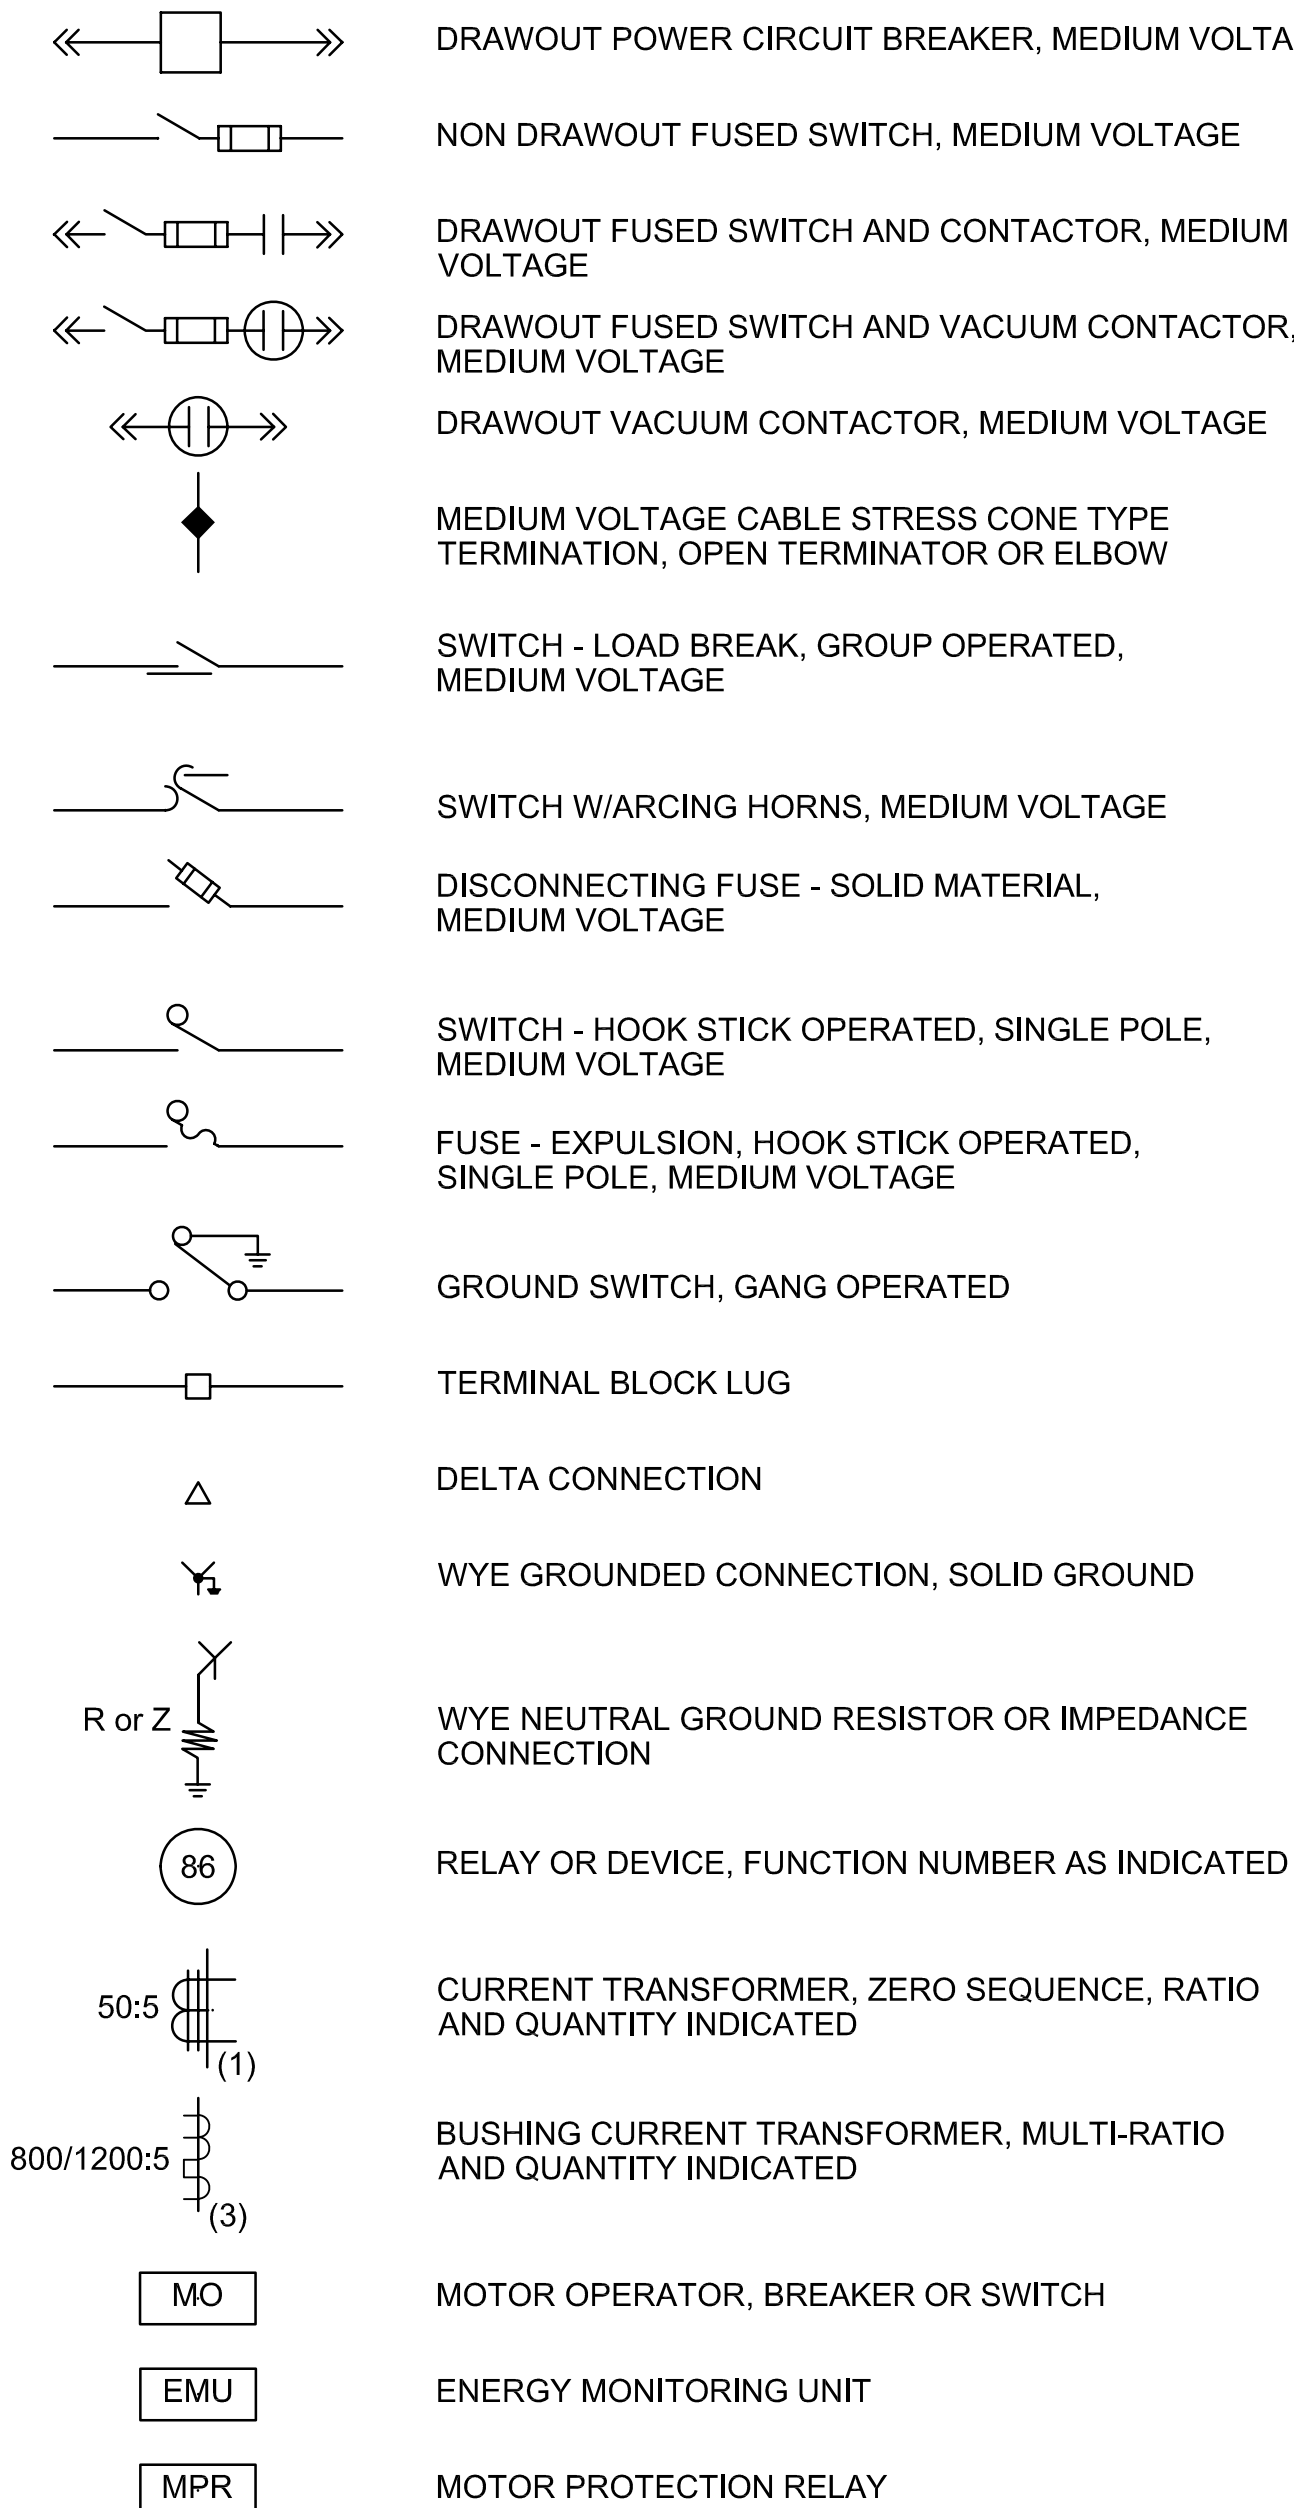


NOTES:
 1. THESE ARE STANDARD LEGEND SHEETS. SOME SYMBOLS AND ABBREVIATIONS MAY APPEAR ON THE LEGEND AND NOT ON THE DRAWINGS.
 2. FOR ADDITIONAL ABBREVIATIONS OF OTHER DIVISIONS (HVAC, MECHANICAL, AND STRUCTURAL/ARCHITECTURAL) SEE OTHER LEGENDS.

SYMBOL

DESCRIPTION


CONTROL DIAGRAMS-1

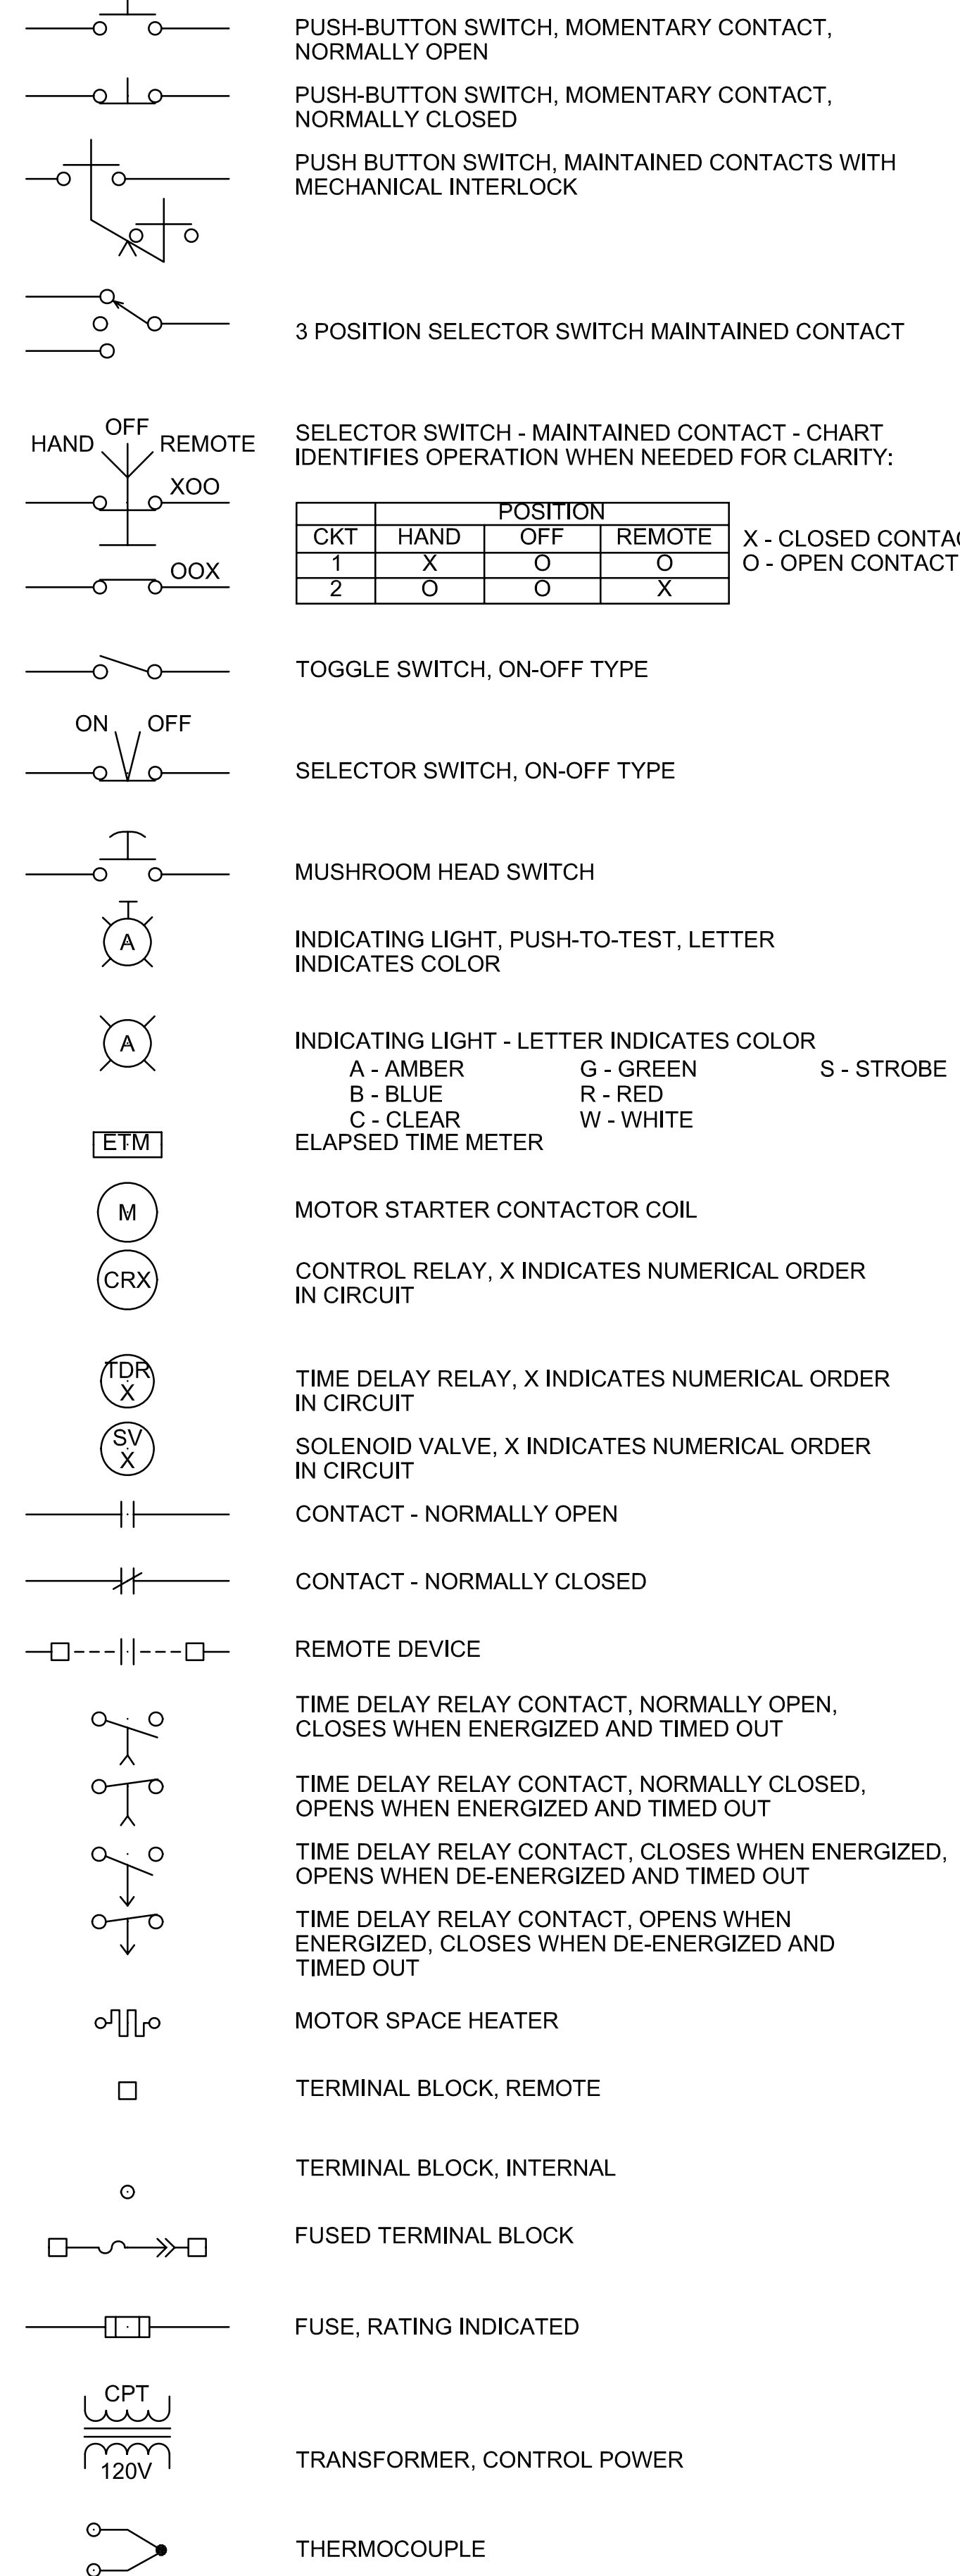

SYMBOL

DESCRIPTION

CONTROL DIAGRAMS-2

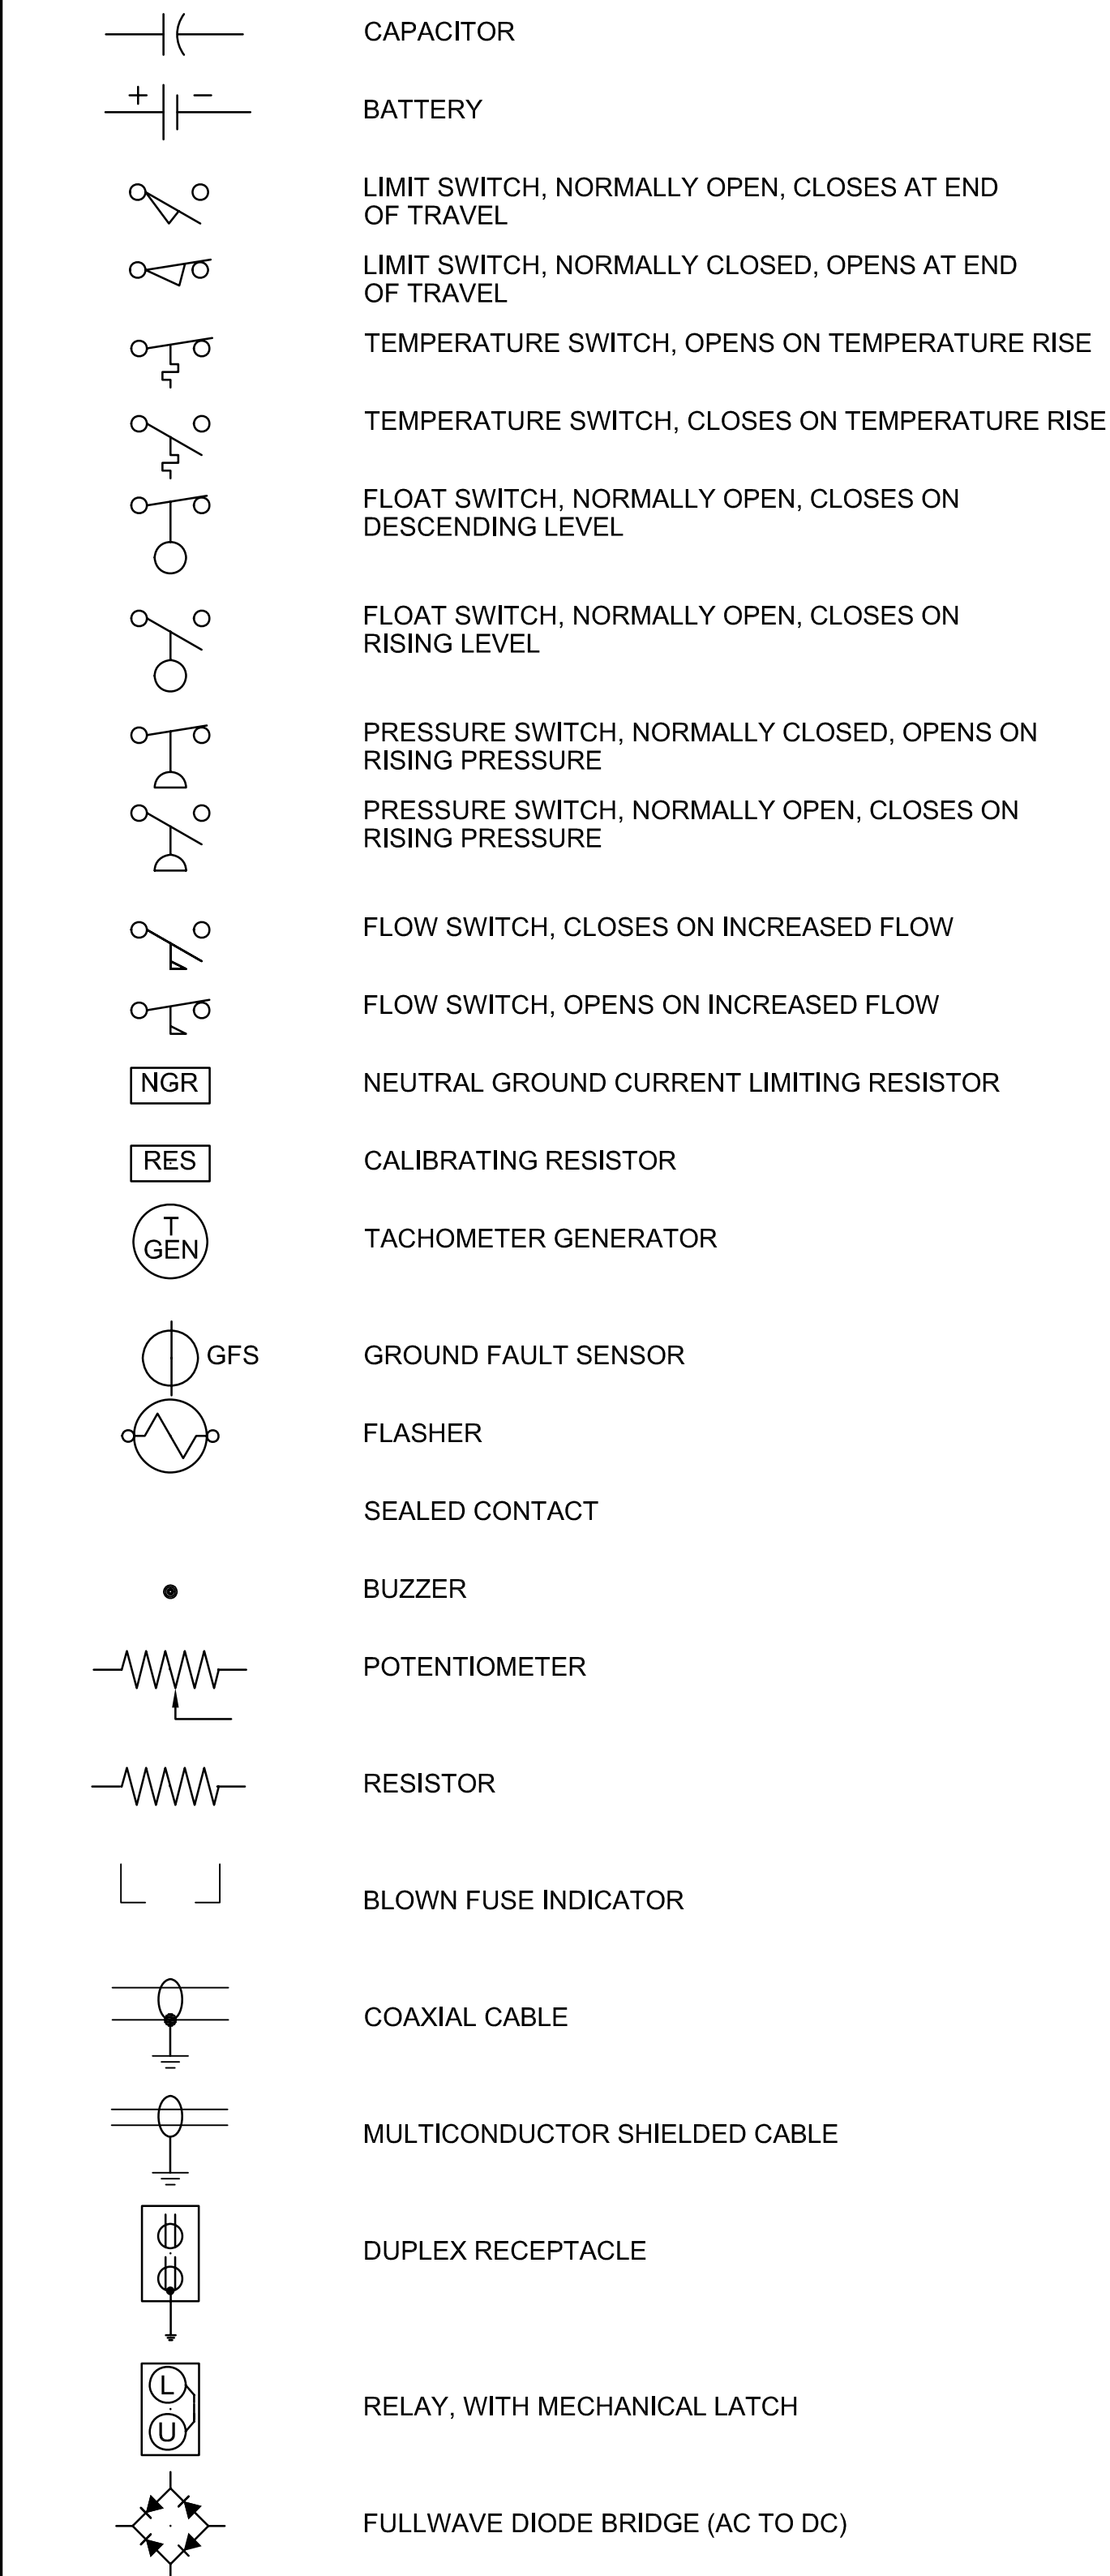

SHEET NUMBER	??
EAST BATON ROUGE	BATON ROUGE
PARRISH	CITY
PROJECT	XX-XX-XX-XXXX
DESIGNED	CHECKED
DATE	DATE
SHEET	OF
NO.	DATE
REVISION DESCRIPTION	
PROJECT NAME	
ELECTRICAL LEGEND - 2	