


PROJECT NO.	SHEET

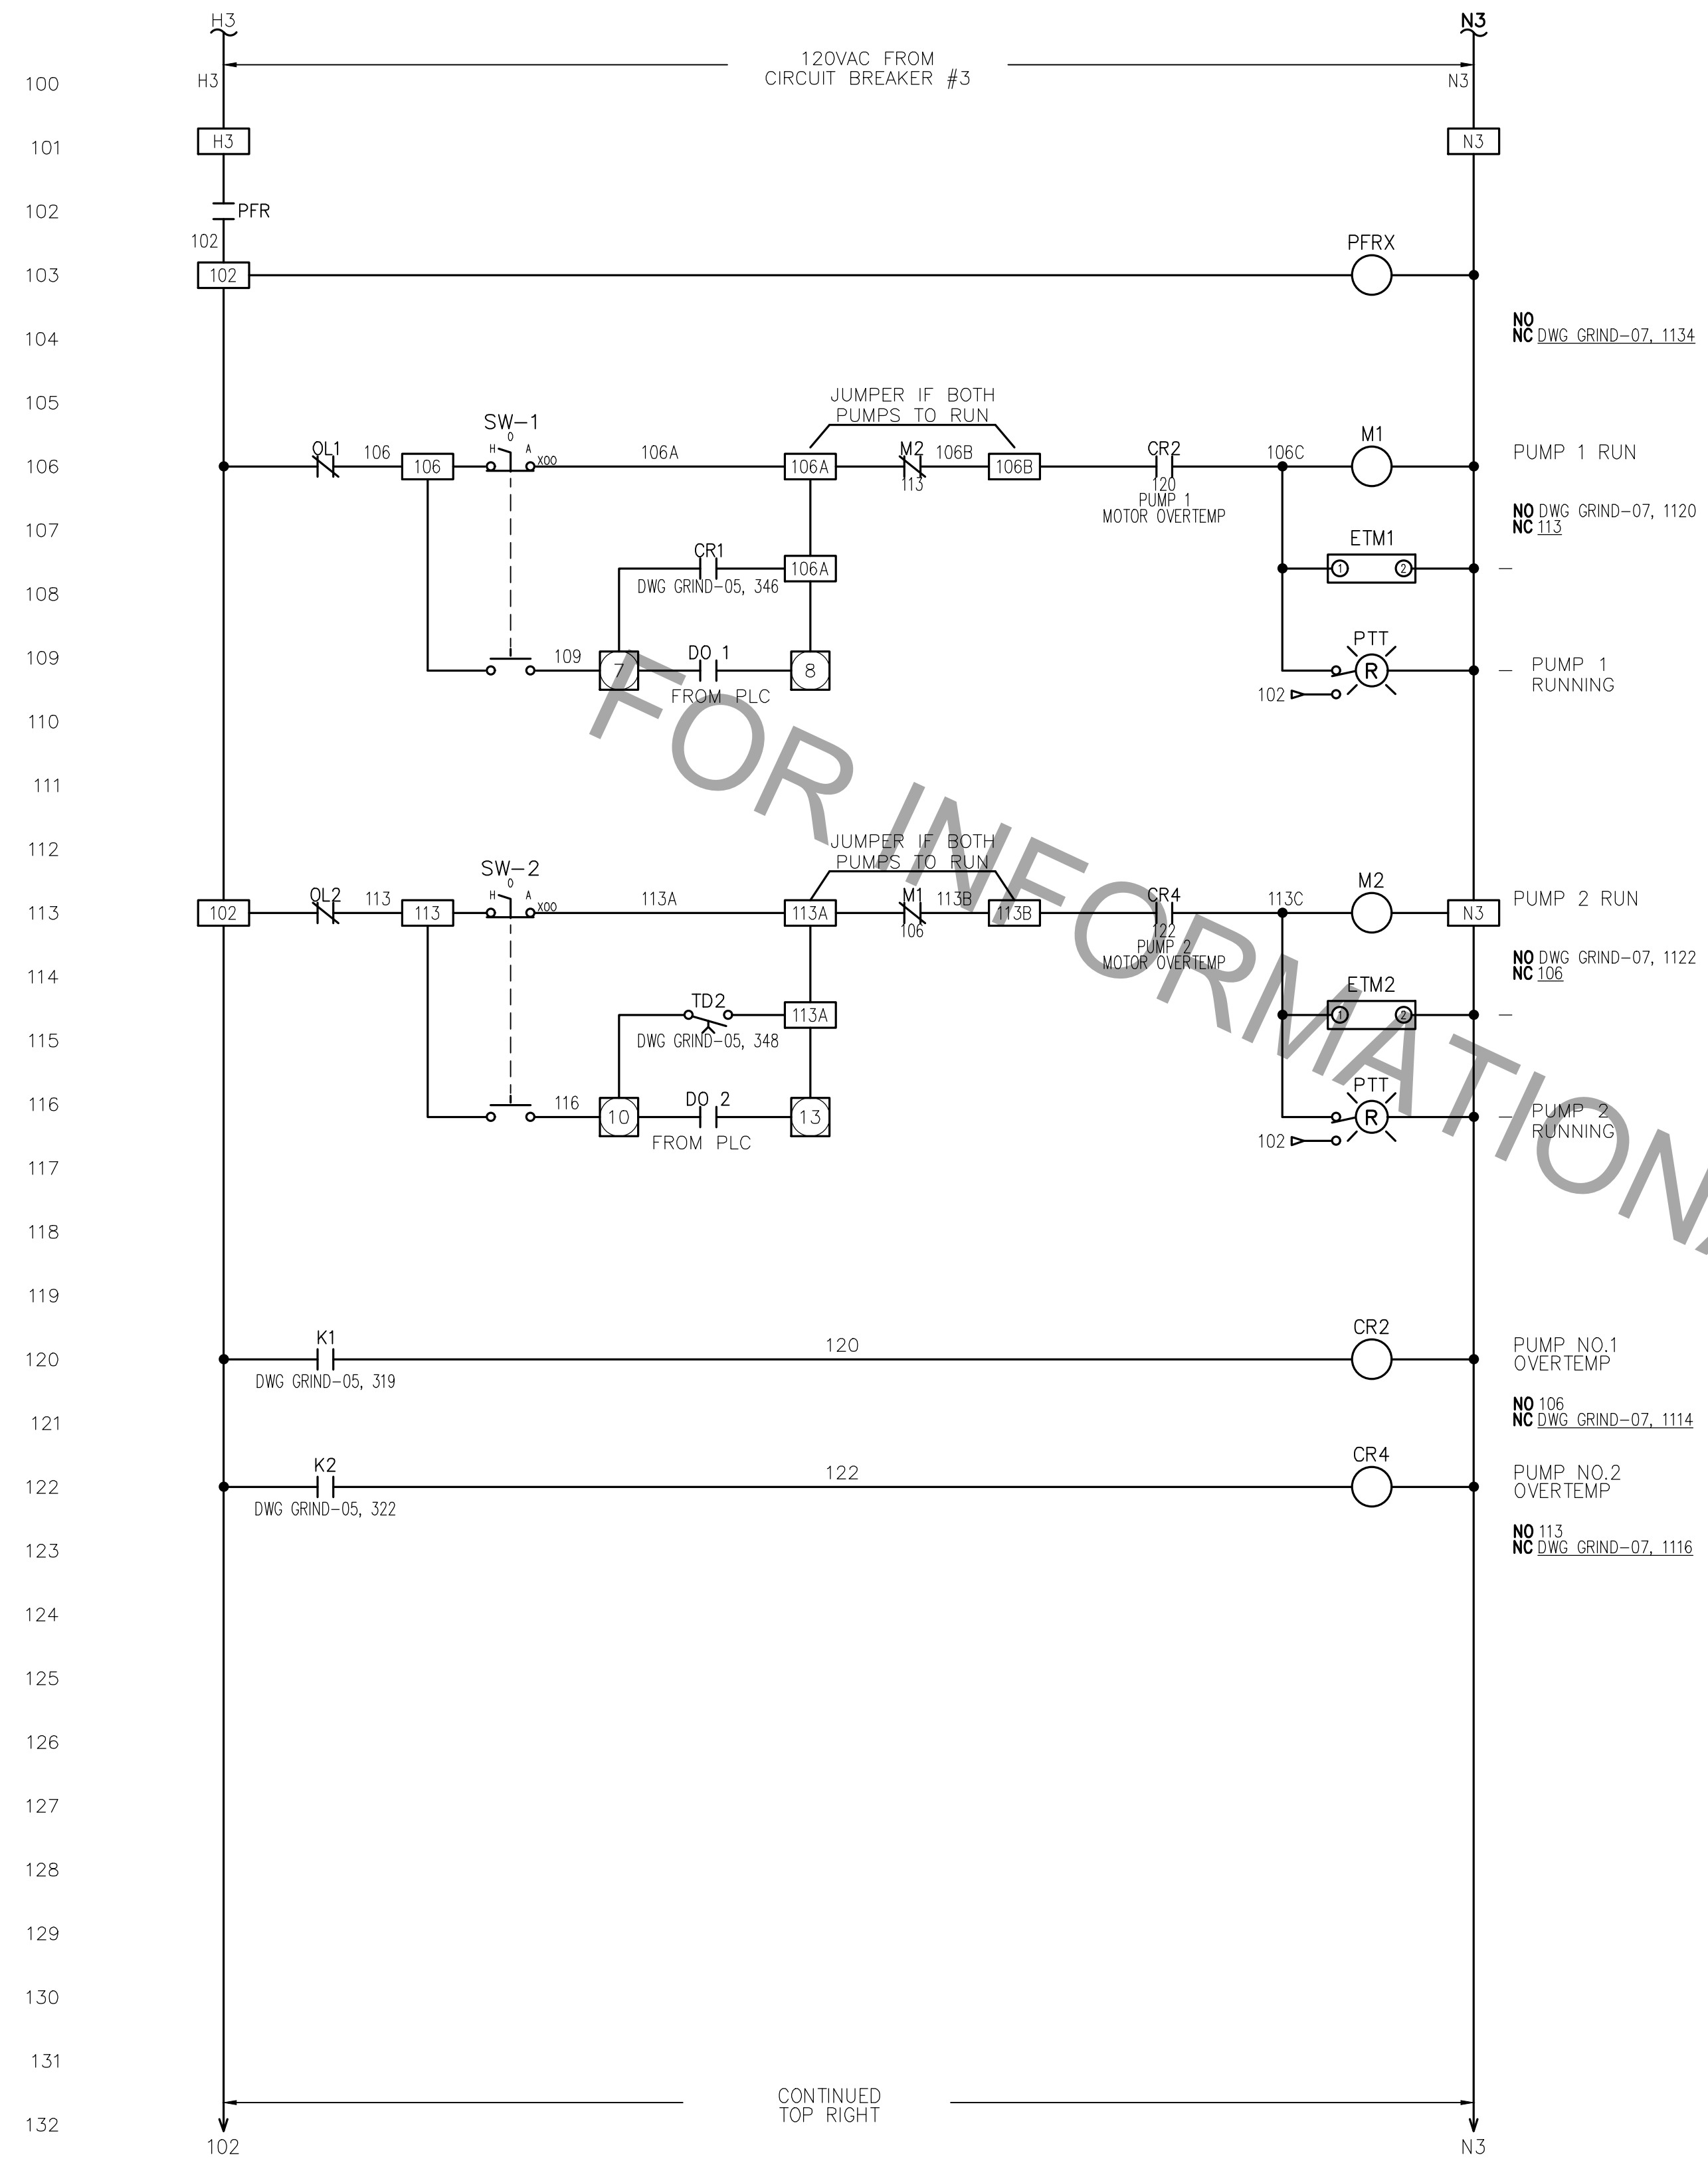

PUMP CONTROL POWER DISTRIBUTION

FOR INFORMATIONAL PURPOSES ONLY



STANDARD PLAN NO. 805-21	DATED NOVEMBER 12, 2020	SHEET NO. 1 OF 3
------------------------------------	----------------------------	---------------------

**PLC POWER DISTRIBUTION
AND PUMP CONTROL DIAGRAM
(TYPE IA STATION)**

ENGINEERING DIVISION DEPARTMENT OF PUBLIC WORKS CITY OF BATON ROUGE & PARISH OF EAST BATON ROUGE			
DESIGNED	DRAWN	CHECKED	APPROVED
A. SMITH	S. CORTEZ		

DATE	DESCRIPTION REVISIONS	BY