



PROJECT NO.	SHEET

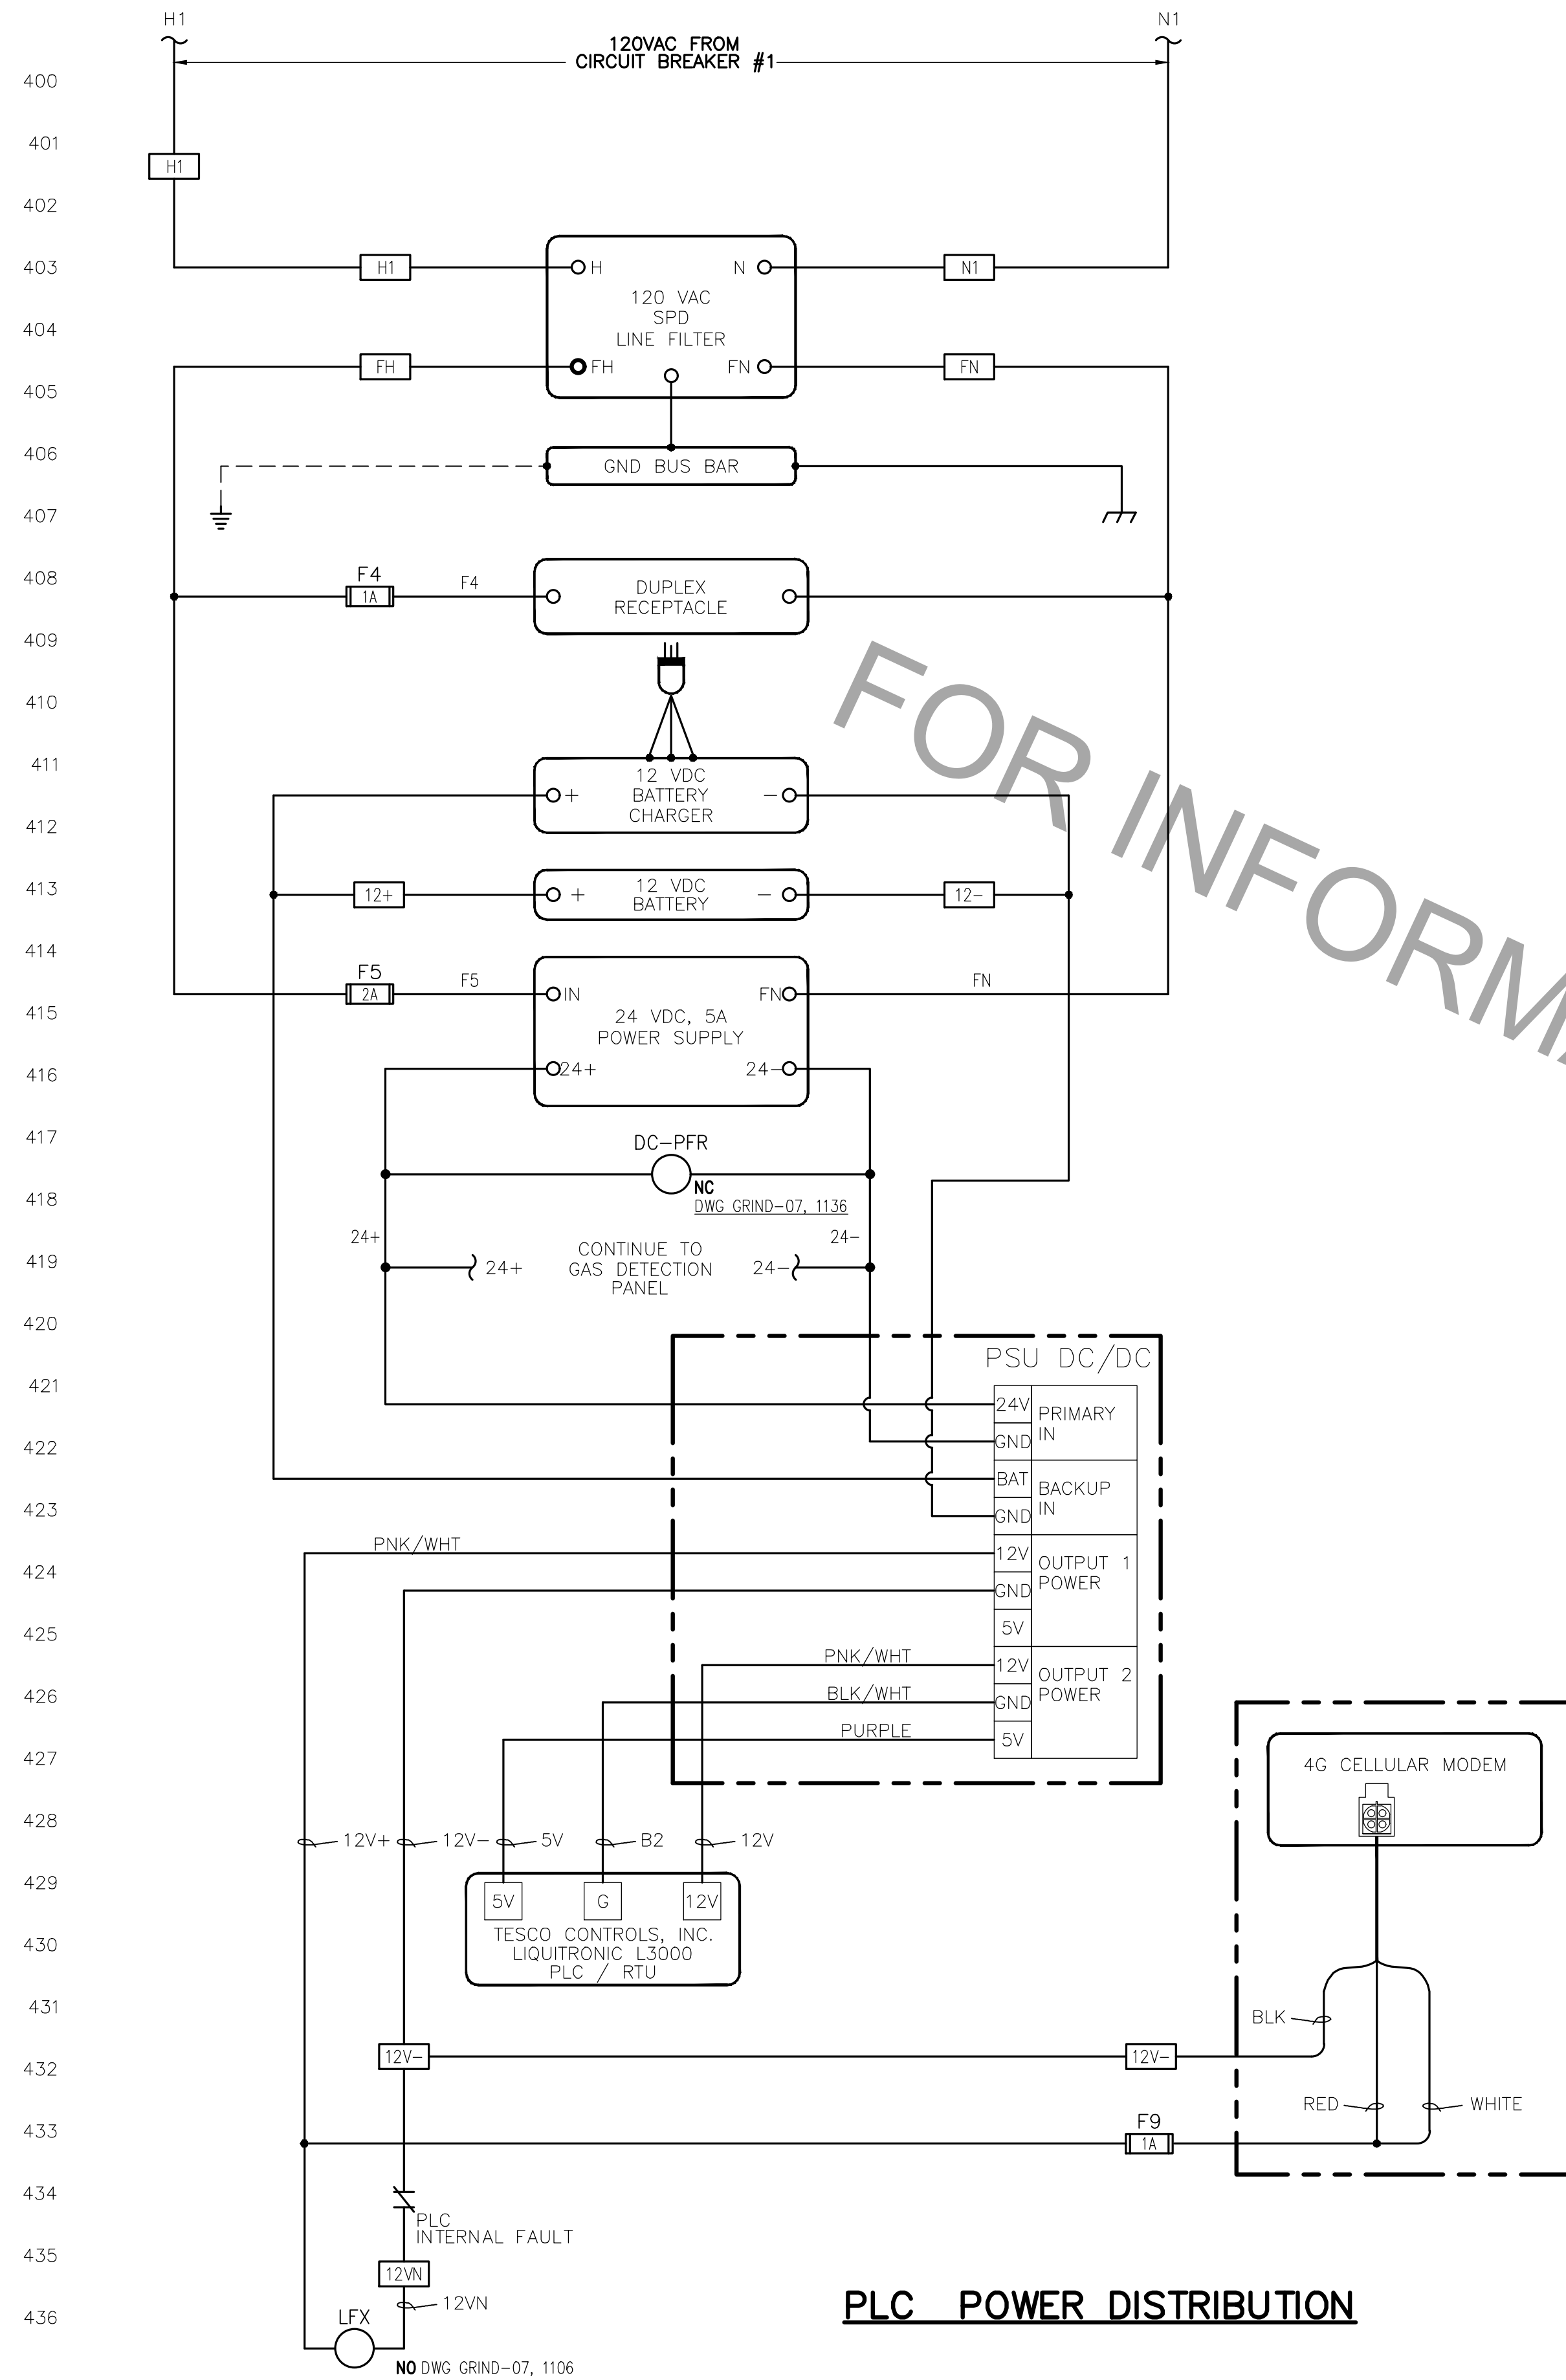


FOR INFORMATIONAL PURPOSES ONLY

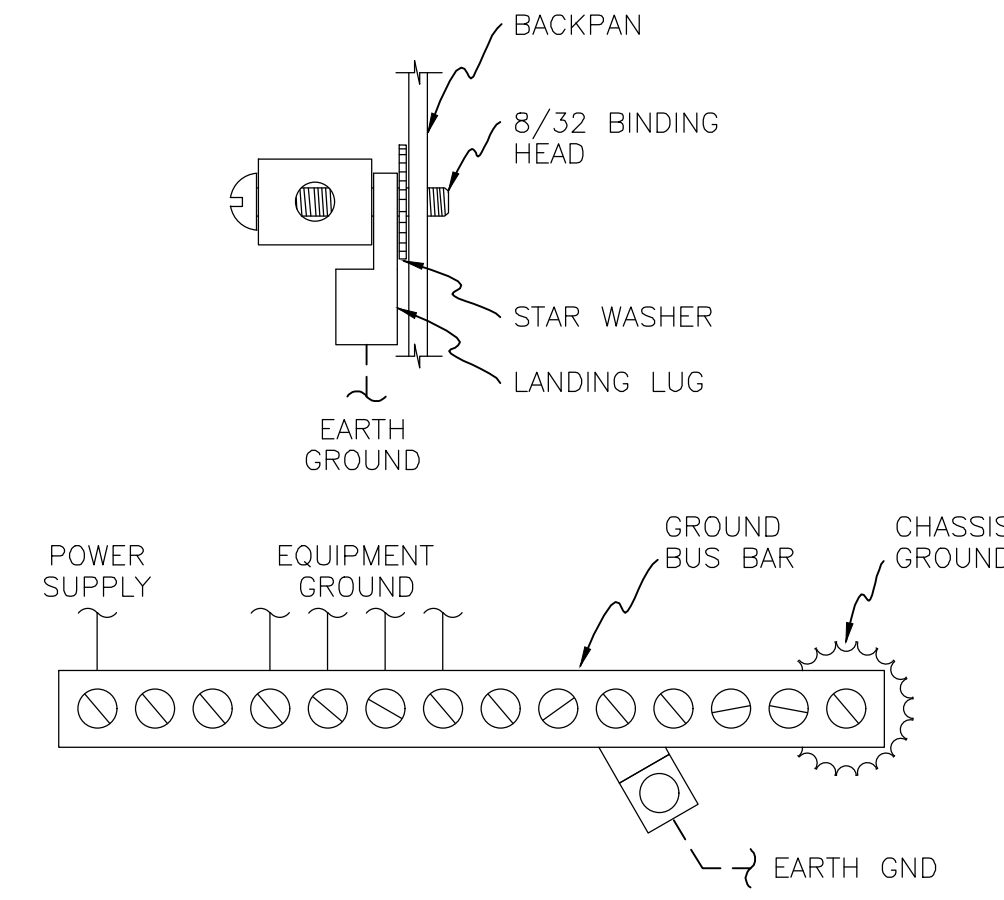

EQUIPMENT GROUNDING DETAIL
(NOT TO SCALE)

POWER SUPPLY RATING	
24 VDC, 5.0 AMP	AUXILLARY POWER (4.0 A)
BATTERY & CHARGER CAPACITY	
12 AMP-HOUR SLA GEL-CELL BATTERY	800mA BATTERY CHARGER
18 AMP-HOUR SLA GEL-CELL BATTERY	2 AMP BATTERY CHARGER
40 AMP-HOUR SLA GEL-CELL BATTERY	4 AMP BATTERY CHARGER

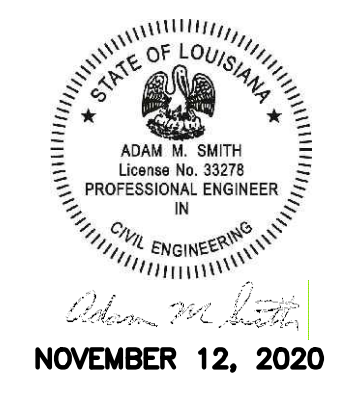

STANDARD PLAN NO. 805-21	DATED NOVEMBER 12, 2020	SHEET NO. 3 OF 3
------------------------------------	----------------------------	---------------------

**PLC POWER DISTRIBUTION
AND PUMP CONTROL DIAGRAM
(TYPE IA STATION)**

ENGINEERING DIVISION DEPARTMENT OF PUBLIC WORKS CITY OF BATON ROUGE & PARISH OF EAST BATON ROUGE			
DESIGNED	DRAWN	CHECKED	APPROVED
A. SMITH	S. CORTEZ		

DATE	DESCRIPTION REVISIONS	BY