


PROJECT NO.	SHEET

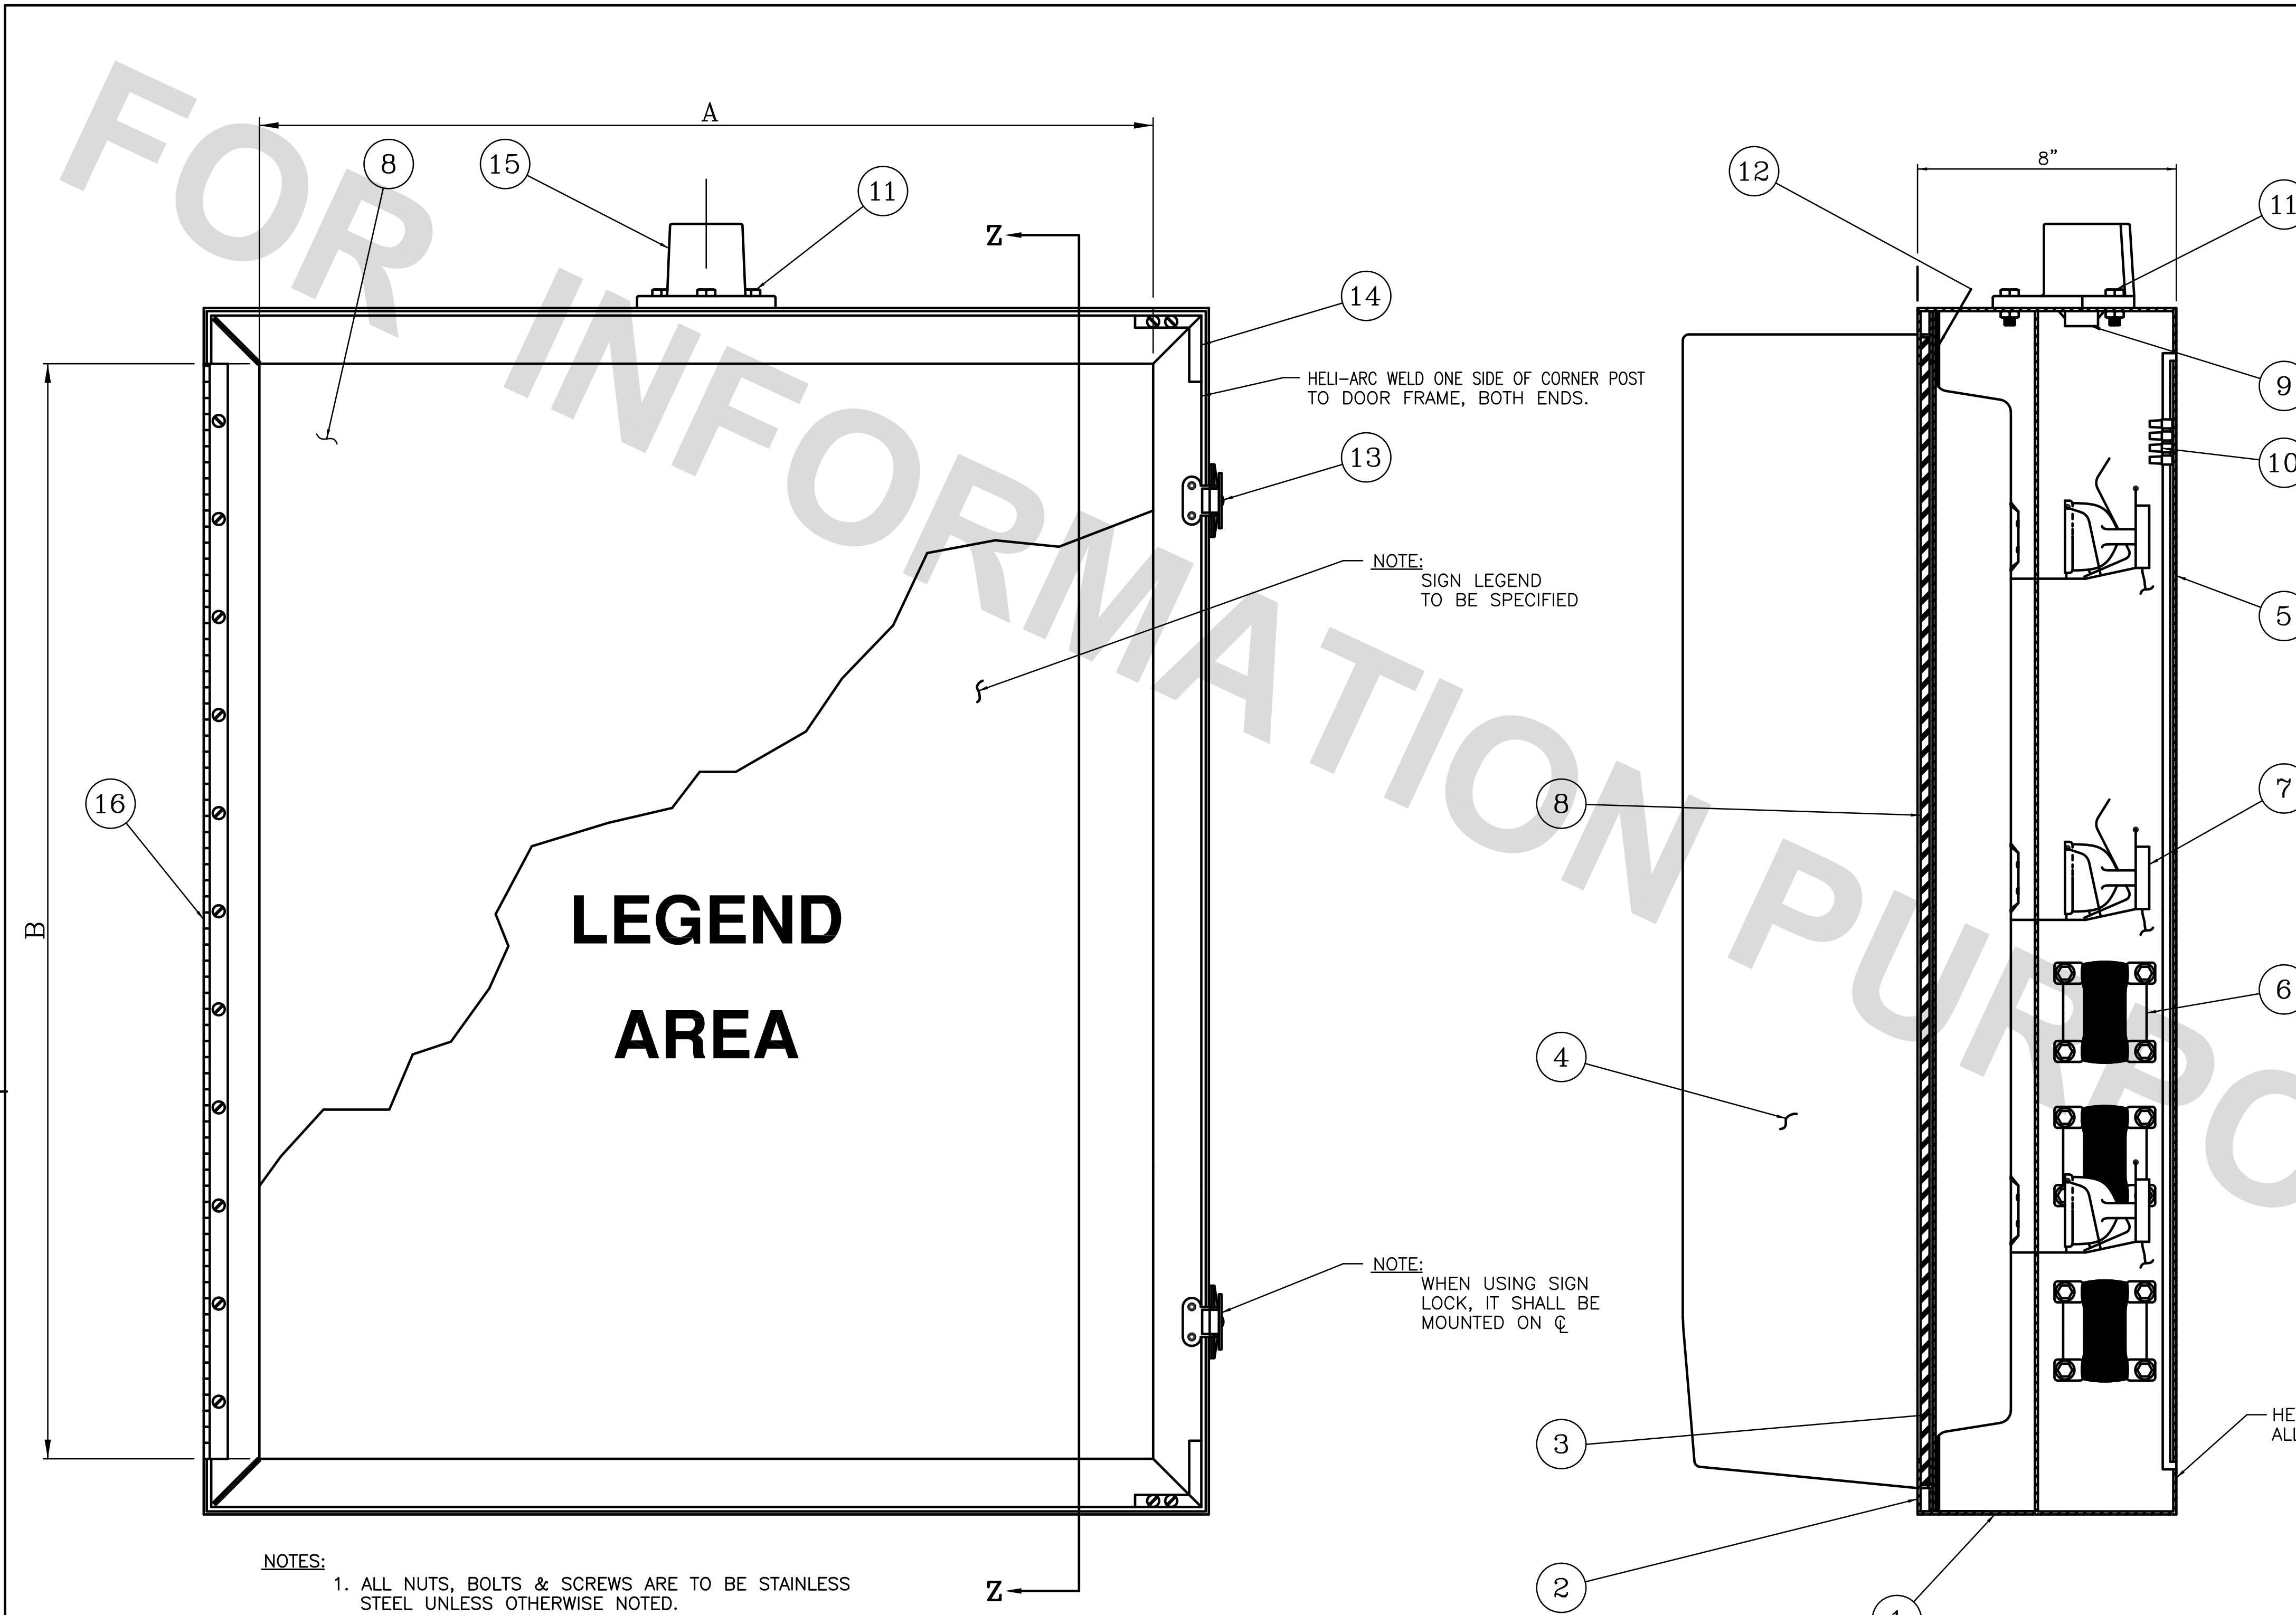

ITEM	DESCRIPTION	QTY.
1	CASE, .125" ALUMINUM	1
2	DOOR FRAME, .125" ALUMINUM	1
3	SIGNAL FACE PLATE, .125" ALUMINUM	1
4	FACE HOOD, .063" ALUMINUM	1
5	SIGNAL BACK PLATE, .063" ALUMINUM	1
6	TRANSFORMERS, 10.8 VOLT, 48.5 VOLT-AMPS.	6
7	E.N.L. LAMP	6
8	CLEAR POLYCARBONATE LENS .125" THICK	1
9	WIRE ENTRY BUSHING	1
10	TERMINAL BLOCK, BARRIER TYPE	1
11	5/16" X 1" STAINLESS STEEL HEX HEAD BOLT & NUT	3
12	DOOR GASKET	1
13	LINK-LOCK, STAINLESS STEEL	2
14	DOOR FRAME CORNER POST	2
15	CAST ALUMINUM ALLOY MOUNTING HUB (1 1/2" STANDARD PIPE THREAD)	1
16	HINGE, STAINLESS STEEL	1
17	FIBER OPTIC END TIPS	215

- NOTES:
1. ALL NUTS, BOLTS & SCREWS ARE TO BE STAINLESS STEEL UNLESS OTHERWISE NOTED.
 2. LEGEND AREA SHALL BE DESIGNED IN ACCORDANCE WITH THE LATEST MUTCD STANDARDS. DIMENSIONS "A" AND "B" SHALL BE SIZED AS SPECIFIED IN THE LATEST MUTCD, THE FRAME SHALL NOT BE INCLUDED FOR THE PURPOSES OF MEETING THE REQUIRED SIGN SIZE.

BLANK OUT SIGN TYPICAL DETAIL



STANDARD PLAN NO. 906-03	DATED September 10, 2019	SHEET NO. 5 OF 5
-----------------------------	-----------------------------	---------------------

ELECTRICAL DETAILS
(BLANK OUT)
SIGN DETAIL

ENGINEERING DIVISION DEPARTMENT OF TRANSPORTATION AND DRAINAGE CITY OF BATON ROUGE & PARISH OF EAST BATON ROUGE			
DESIGNED	DRAWN	CHECKED	APPROVED
T.E.D.	G. VANNICE	S. EDEL	I. PARTENHEIMER

DATE	DESCRIPTION	BY
	REVISIONS	

ENGINEERING AUTHORITY STUDY FORM 03